


420 PEOPLE DANCE COMPANY
 LIGHTING PLOT: WIND UP
 VENUE: ARCHA THEATRE


Velký sál – půdorys – tahy

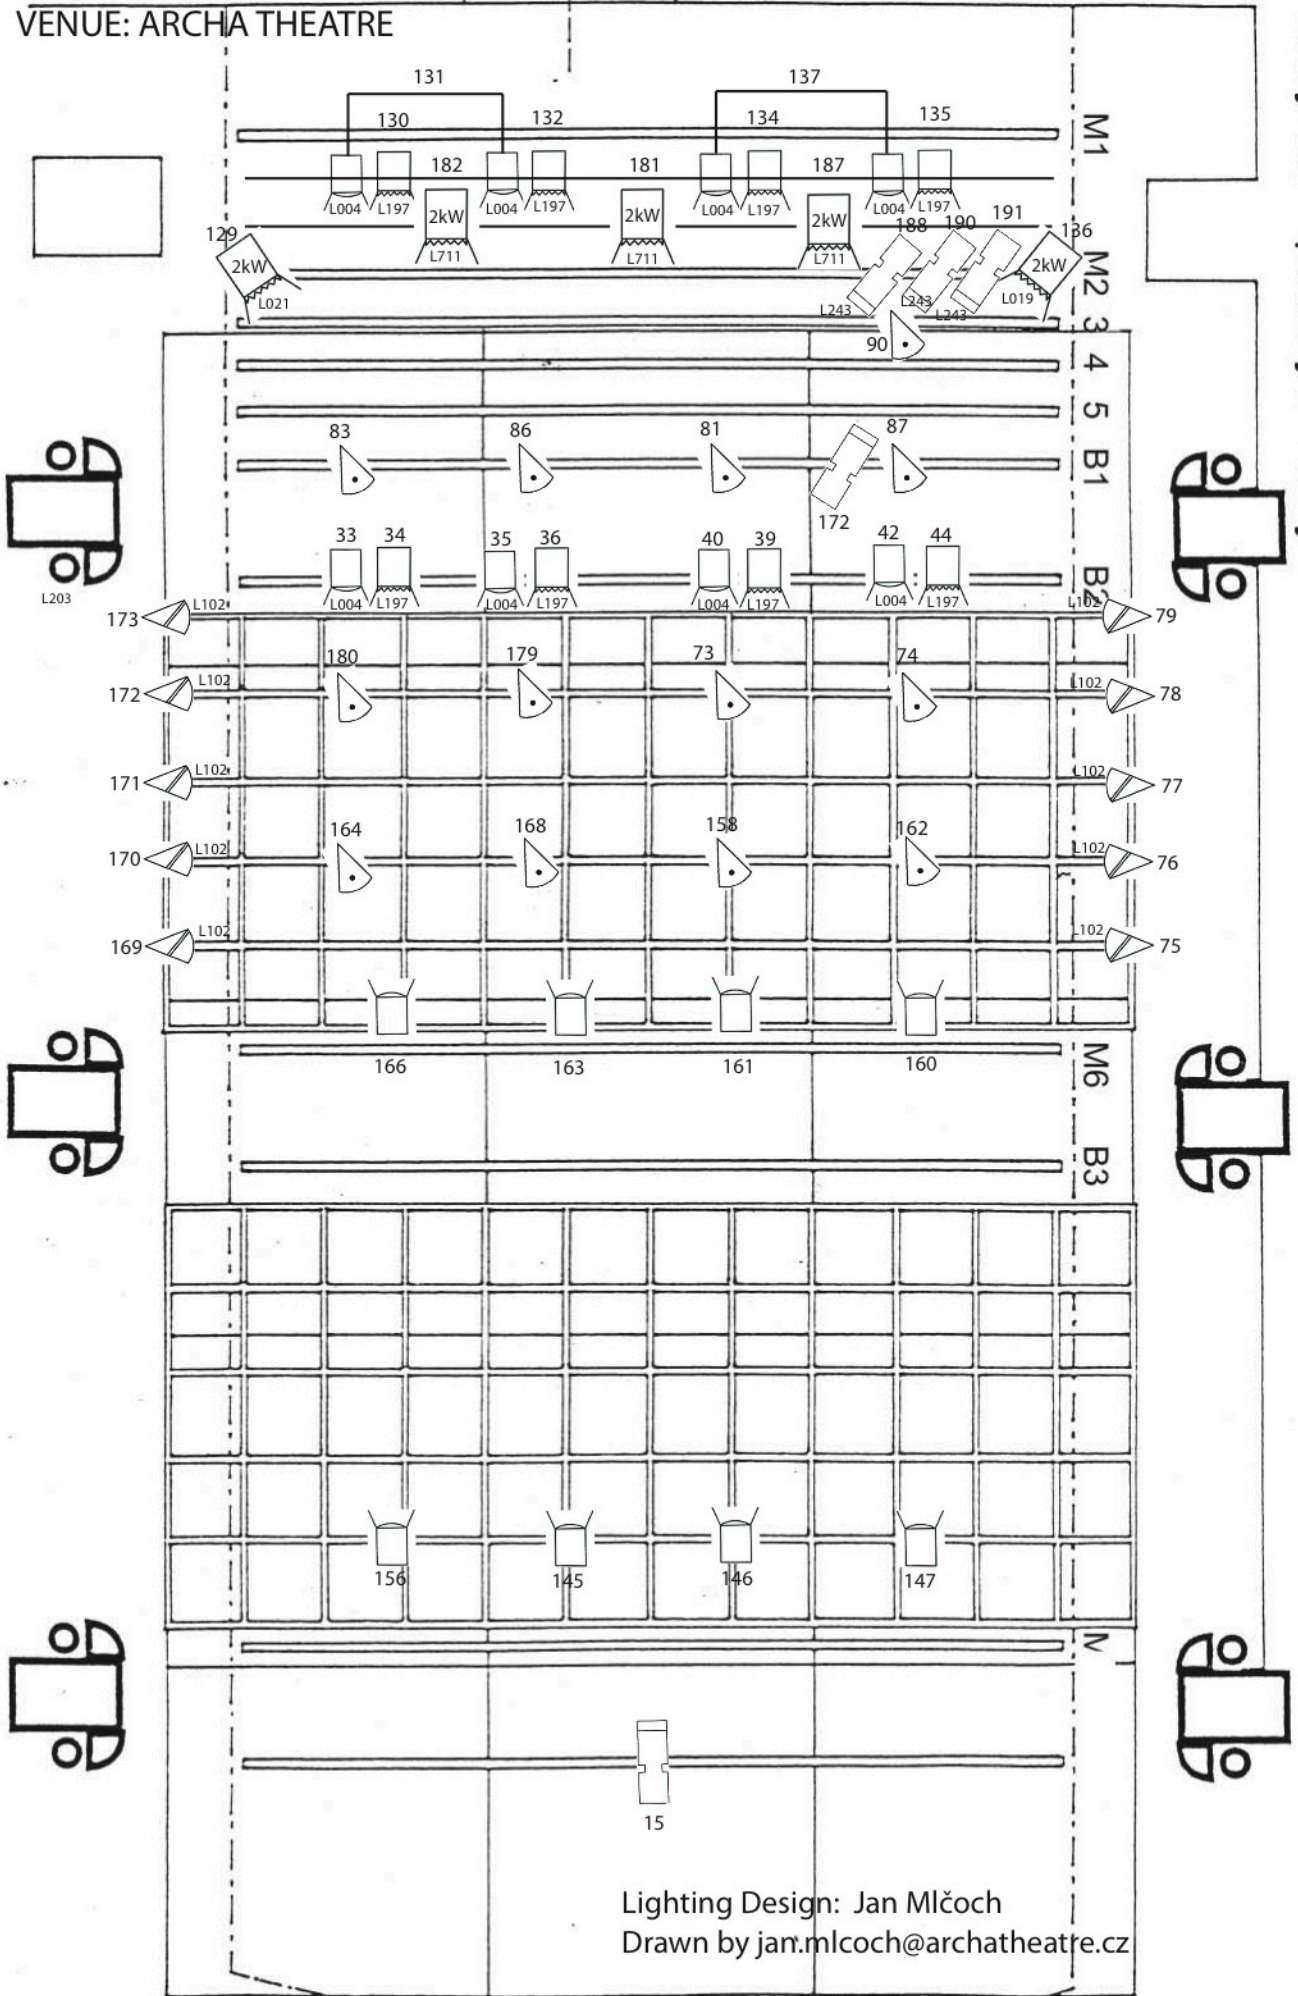

Lighting Design: Jan Mlčoch
 Drawn by jan.mlcoch@archatheatre.cz

420 PEOPLE DANCE COMPANY
 LIGHTING PLOT: WIND UP
 VENUE: ARCHA THEATRE

Velký sál – půdorys – základní rozměry

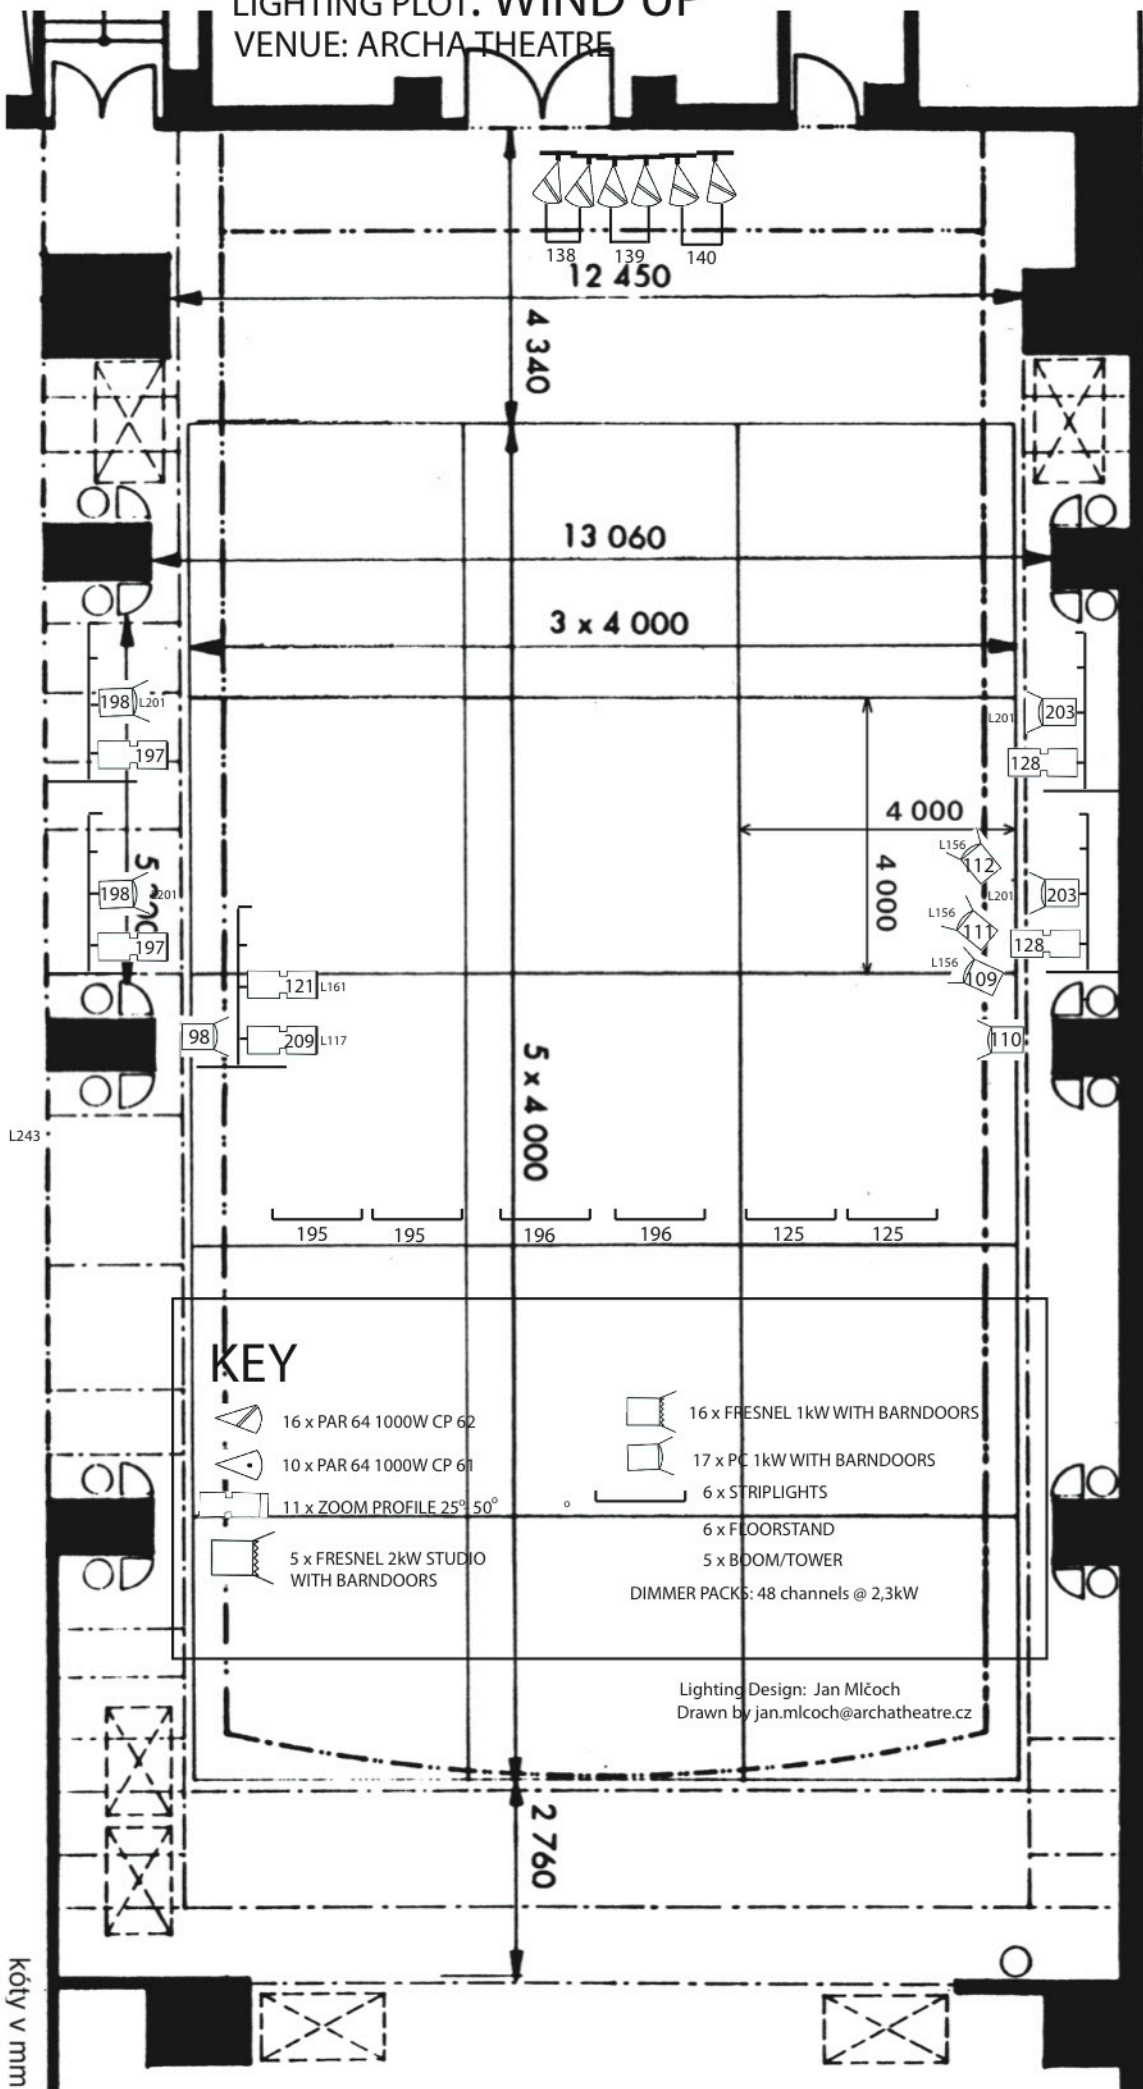

KEY

- 16 x PAR 64 1000W CP 62
- 10 x PAR 64 1000W CP 61
- 11 x ZOOM PROFILE 25° 50°
- 5 x FRESNEL 2kW STUDIO WITH BARNDOORS
- 16 x FRESNEL 1kW WITH BARNDOORS
- 17 x PC 1kW WITH BARNDOORS
- 6 x STRIPLIGHTS
- 6 x FLOORSTAND
- 5 x BOOM/TOWER
- DIMMER PACKS: 48 channels @ 2,3kW

Lighting Design: Jan Mlčoch
 Drawn by jan.mlcoch@archatheatre.cz

kóty v mm